

Account Executive: Heidi Boehmke

Revision Date: 02.08.10

Rev. # 06

Drawn By: Christine Smith

Scale: Fit to Page

LEGEND

□ = UTILITIES FLOOR BOX
WATER AND DRAIN, COMP, AIR 90 PSI,
PHONE 6 PAIR JACK, CONDUIT TO UTILITY TUNNEL
COMBINATION 20 AMP, 120 V & 20 AMP, 208 V 1 PHASE
POWER OUTLET 100 AMP 120/208 V 3 PHASE 4 W

● = DENOTES COLUMNS
● = DENOTES COLUMNS

CEILING HEIGHT

 
EXHIBIT HALL B - UNDIVIDED
CEILING HEIGHT 40'
FLOOR WIDTH 540' DEPTH 510'

EXHIBIT HALL C
CEILING HEIGHT VARIES FROM 18'-2" TO 33'
FLOOR WIDTH 360' DEPTH 300'

SYMBOLS LEGEND


☐ ELEVATOR	☐ PUBLIC TELEPHONES
☐ WOMEN'S ROOM	☐ FIRE STROBE
☐ MEN'S ROOM	☐ FIRE HOSE CABINET
☐ STAIRS DOWN	☐ FIRE EXTINGUISHER
☐ STAIRS UP	☐ WATER FOUNTAIN
☐ UP ESCALATORS	☐ EMERGENCY EXIT
☐ DOWN ESCALATORS	

BOOTHES ARE 10'X10'
TOTAL OF NET SQ.FT. = 150600
AISLES ARE 10' UNLESS NOTED

 NO EXHIBITS WITHIN
20' OF LOBBY DOORS &
DOCK RECESSES

 RESTRICTED RIGGING
AT CEILING

Disclaimer
Every effort has been made to ensure the accuracy of all information contained on this floor plan. However no warranties, either expressed or implied are made with respect to this floor plan. If the location of building columns, utilities or other architectural components of the facility is a consideration in the construction or usage of an exhibit, it is the sole responsibility of the exhibitor to physically inspect the facility to verify all dimensions and locations.

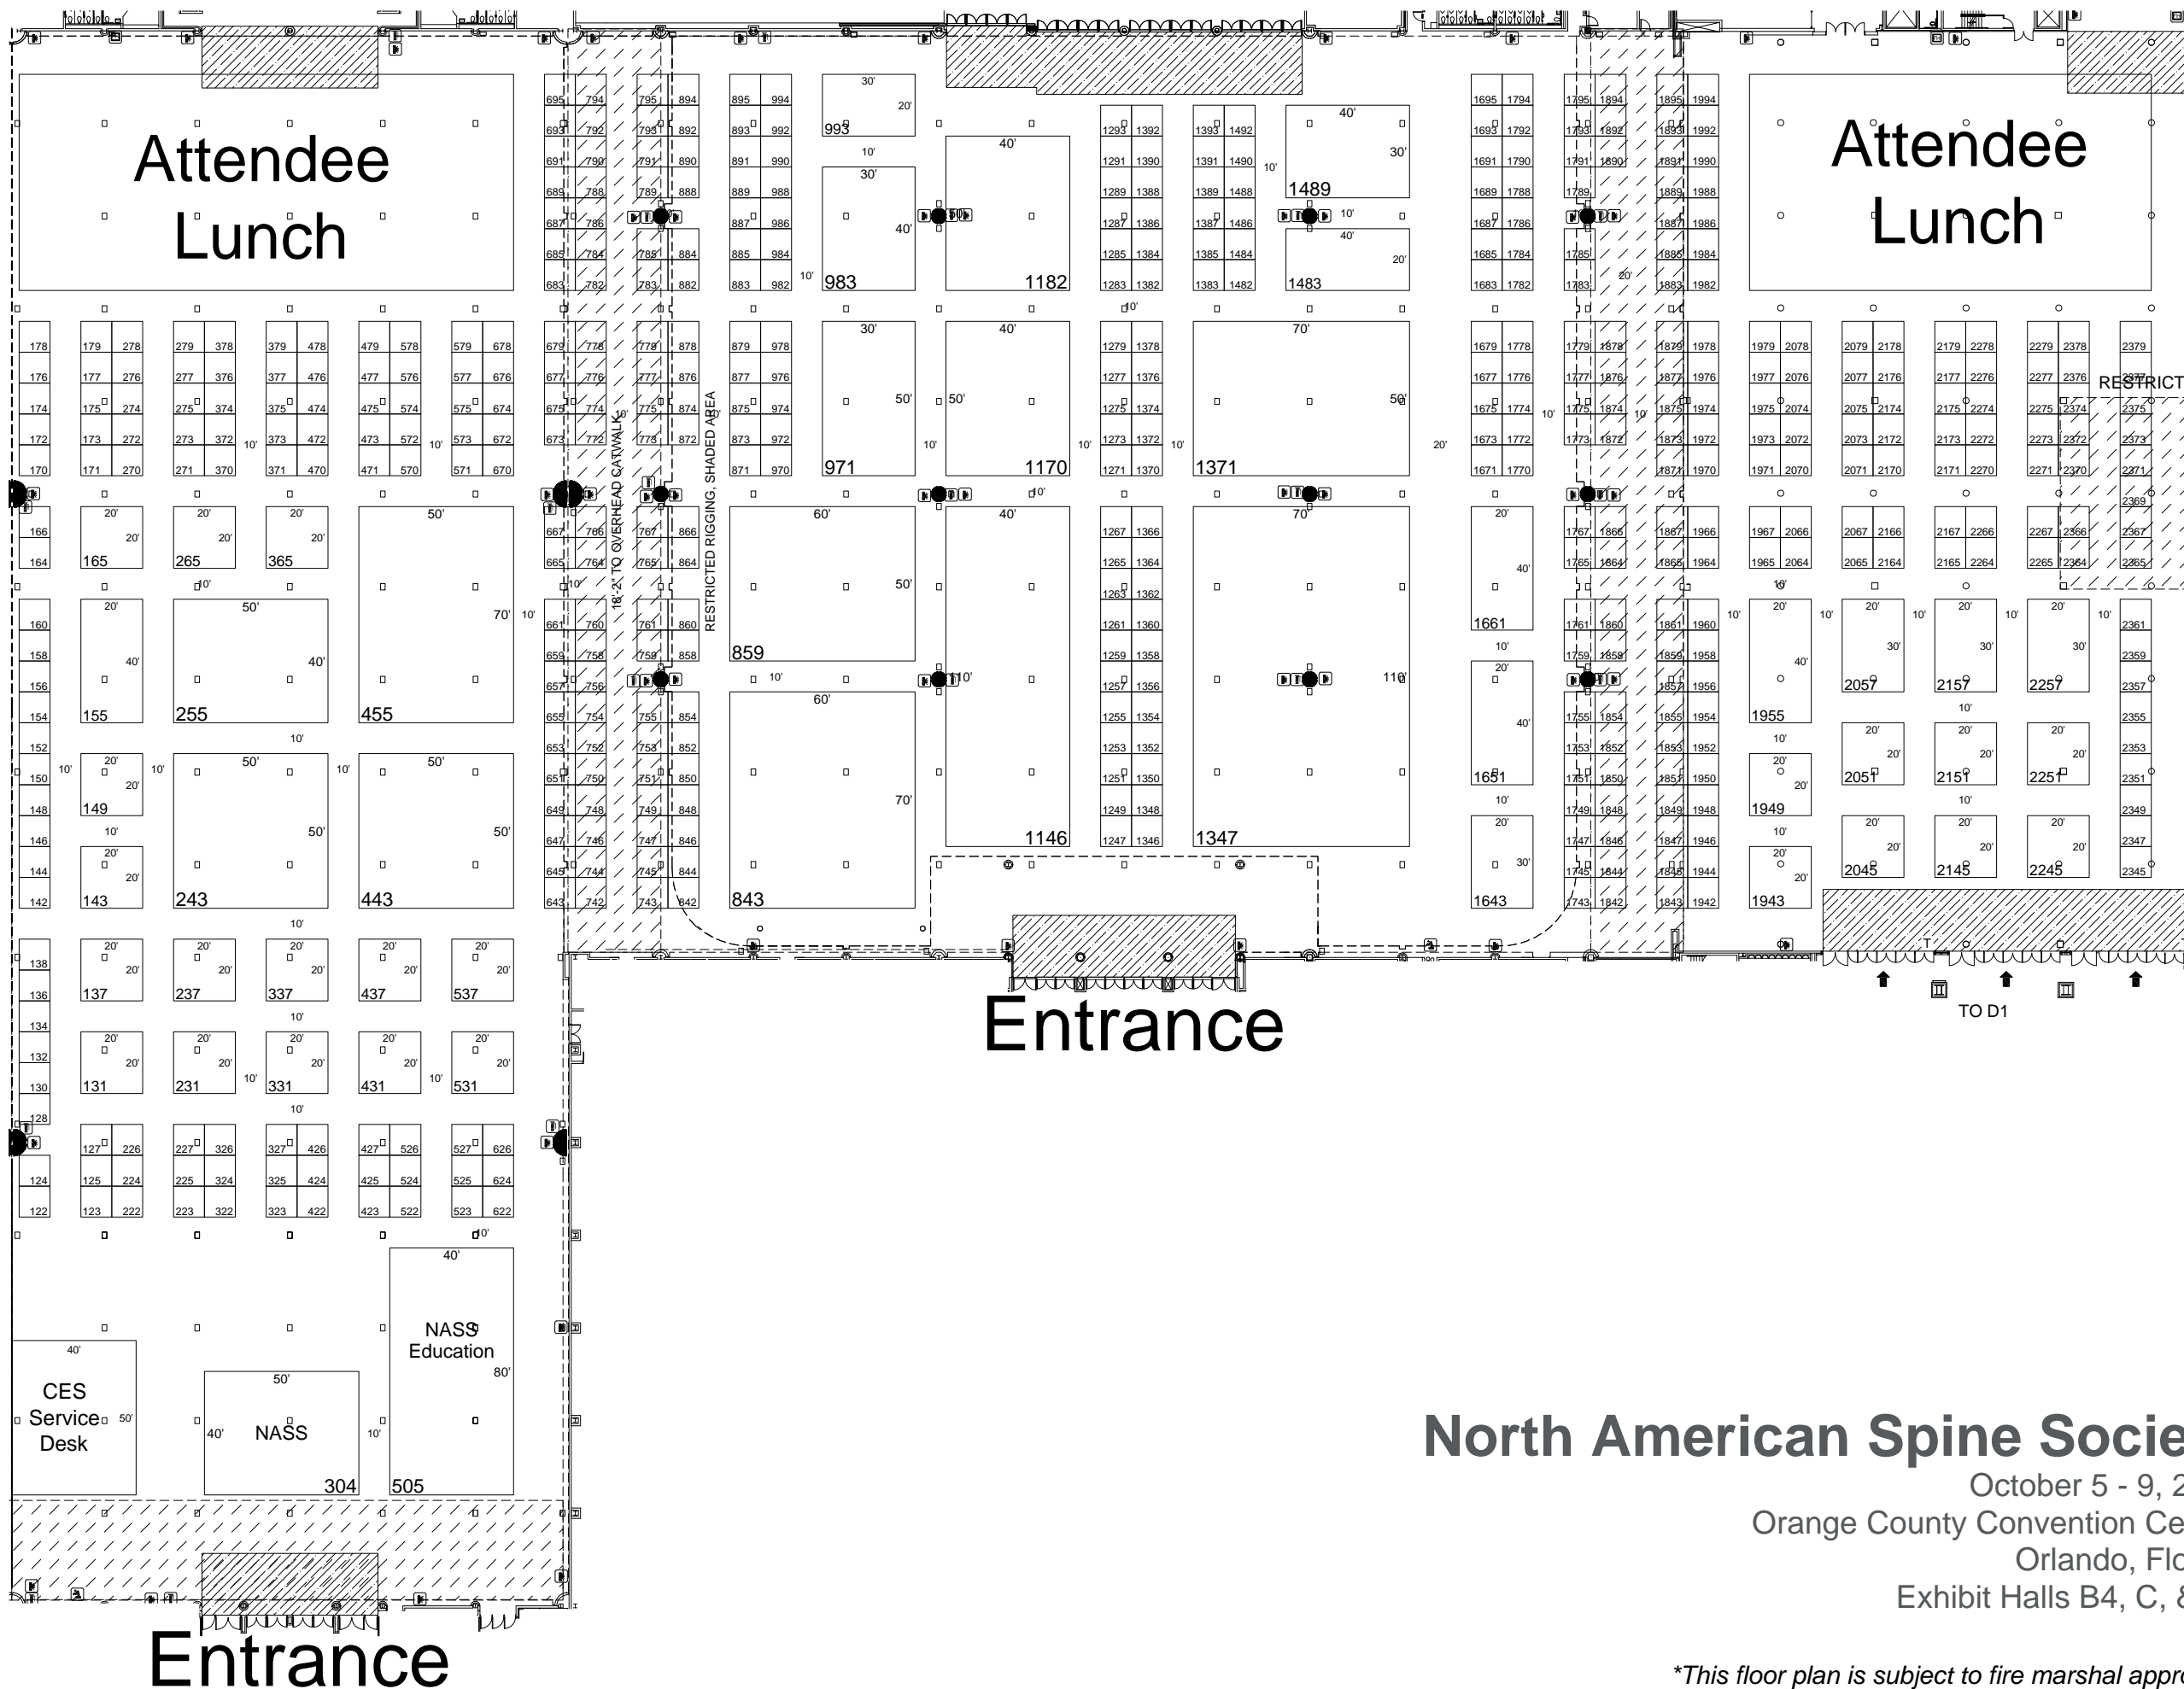

North American Spine Society

October 5 - 9, 2010

Orange County Convention Center

Orlando, Florida

Exhibit Halls B4, C, & D1

**This floor plan is subject to fire marshal approval.*